


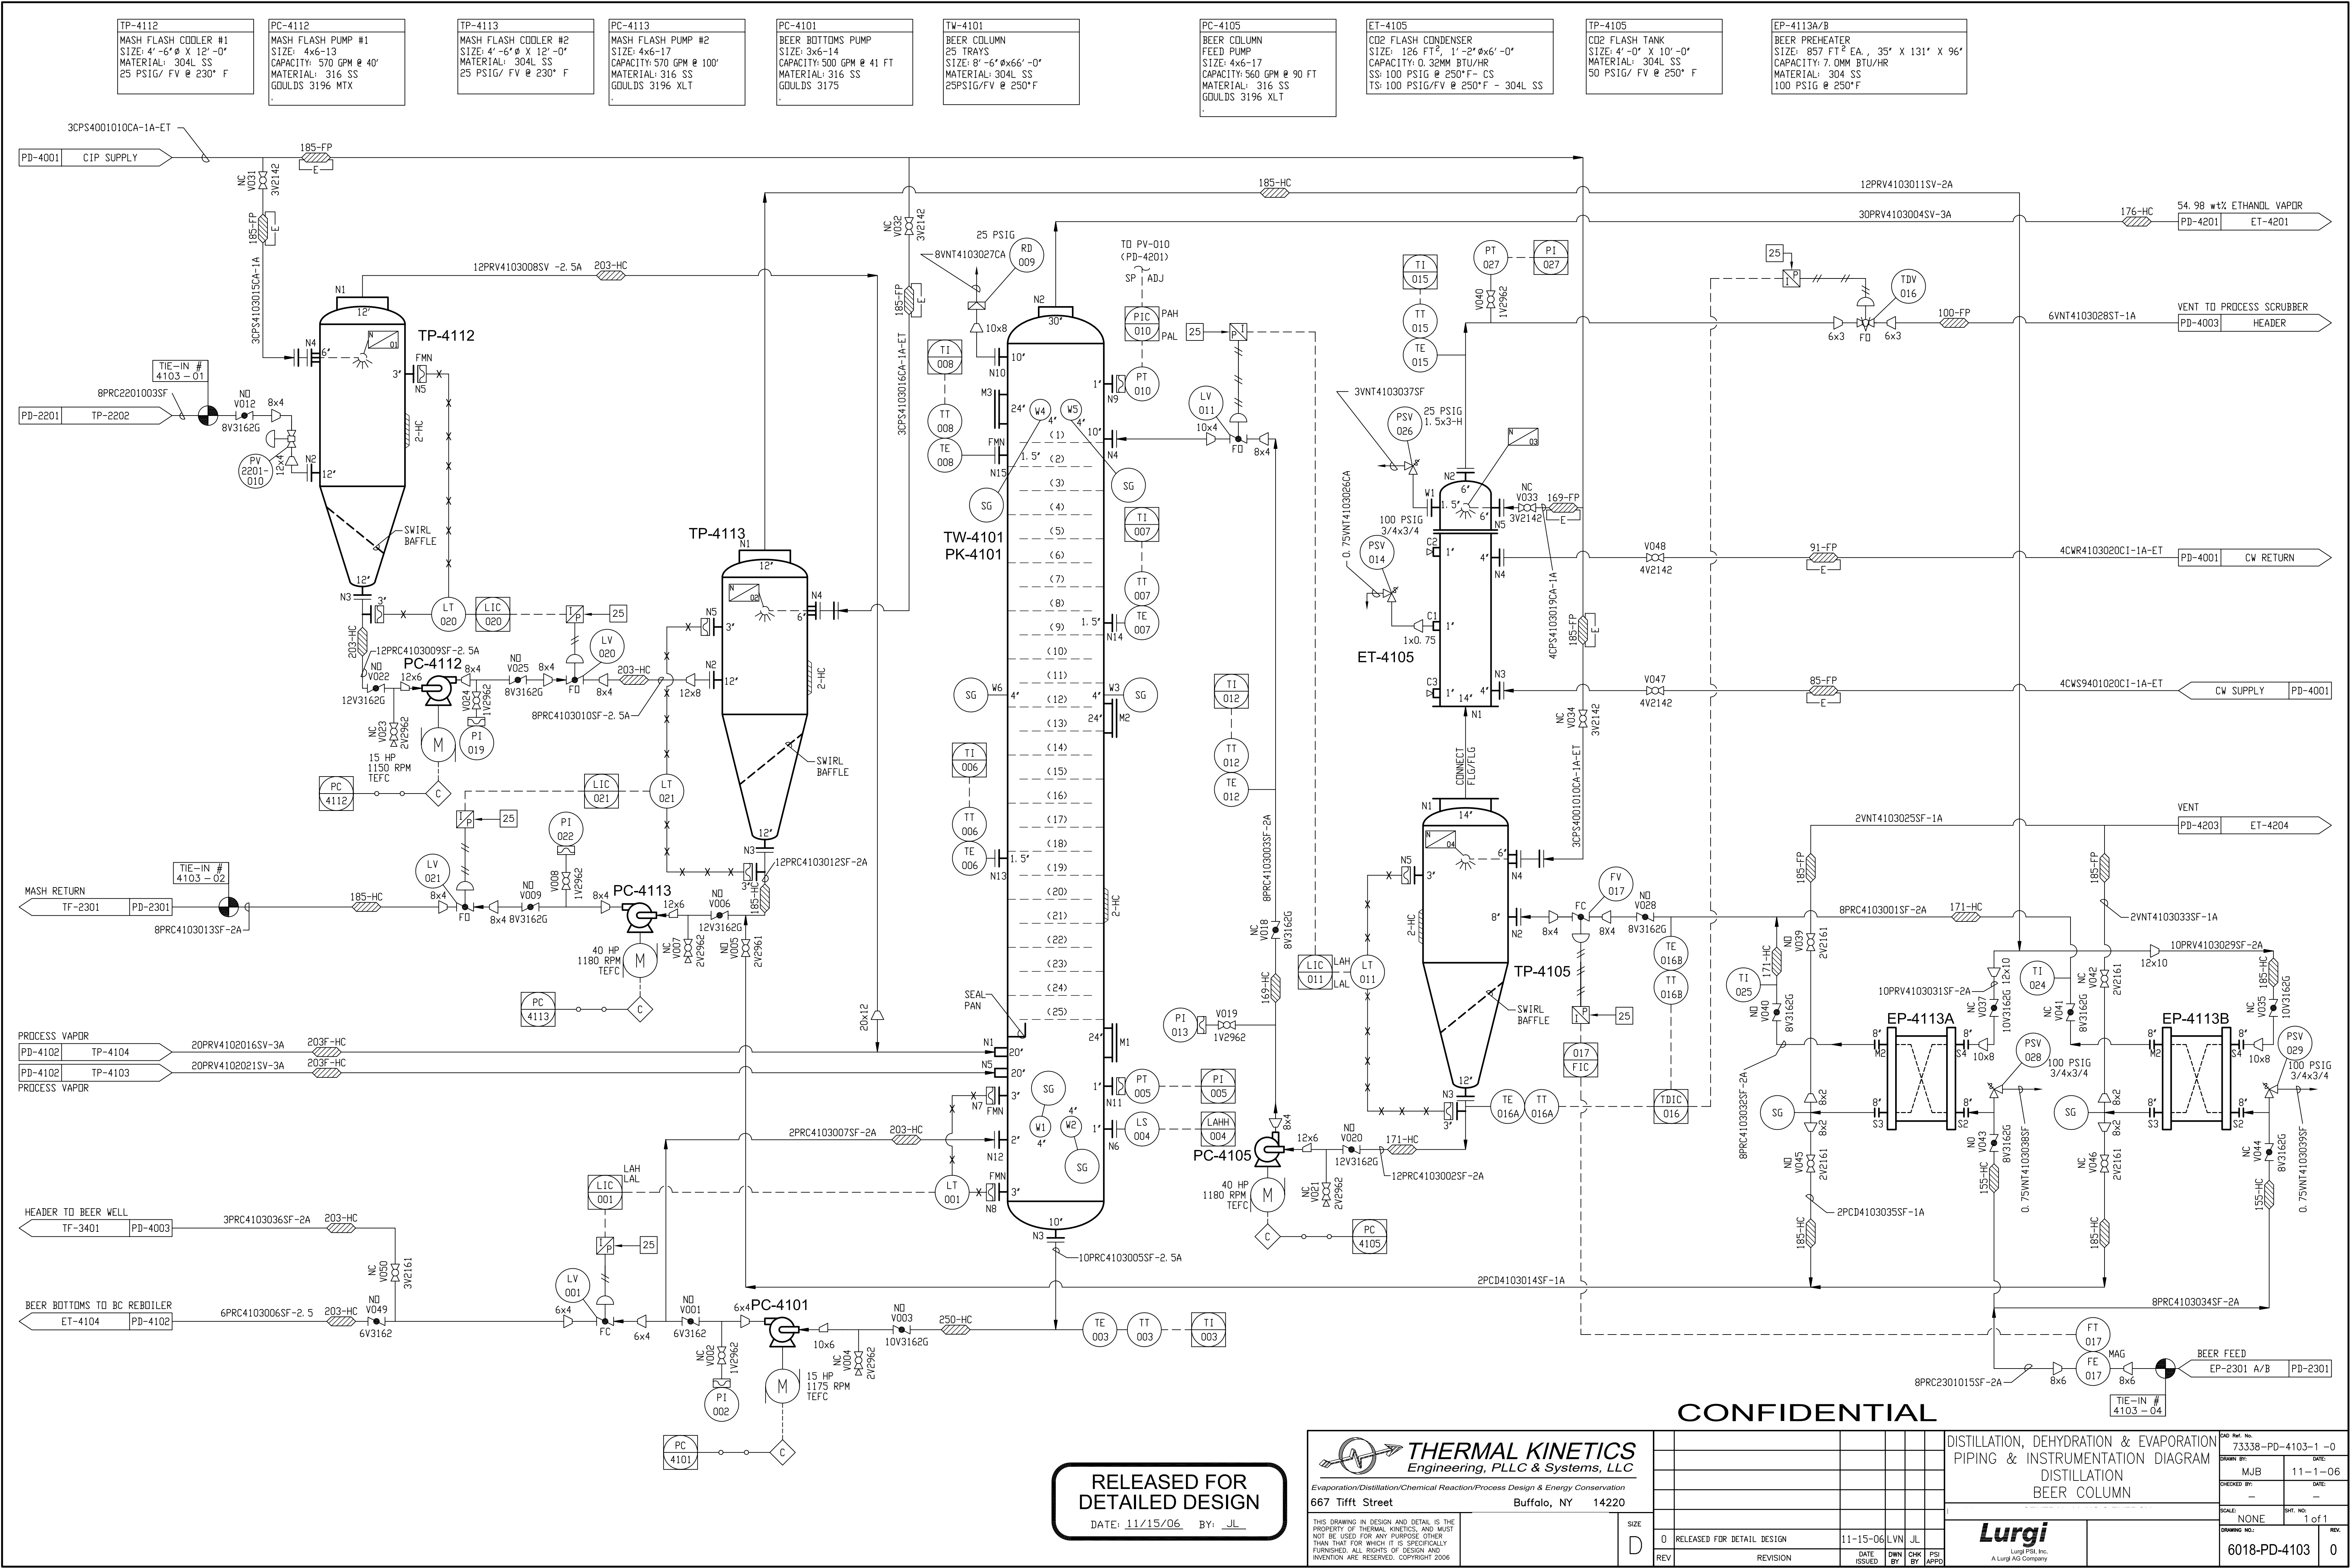

RELEASED FOR
DETAILED DESIGN
DATE: 11/15/06 BY: JL

THERMAL KINETICS
Engineering, PLLC & Systems, LLC
Evaporation/Distillation/Chemical Reaction/Process Design & Energy Conservation
667 Tift Street Buffalo, NY 14220

REV	DESCRIPTION	DATE	BY	CHK	APP
0	RELEASED FOR DETAIL DESIGN	11-15-06	LVN	JL	

DISTILLATION, DEHYDRATION & EVAPORATION PIPING & INSTRUMENTATION DIAGRAM DISTILLATION BEER COLUMN		73338-PD-4103-1-0	DATE: 11-1-06
DRAWN BY: MJB		CHECKED BY: -	DATE: -
SCALE: NONE		SHEET NO: 1 of 1	
DRAWING NO: 6018-PD-4103		REV: 0	

D-SIZE (24x36)