

TP-4207
WHELE STILLAGE FLASH
TANK
SIZE: 4'-0" Ø x 12'-0"
MATERIAL: 304L SS
25PSIG/ FV @ 200°F

PC-4207
WHELE STILLAGE FLASH
PUMP
SIZE: 3x6-14-5V
CAPACITY: 440 GPM @ 80'
MATERIAL: 304L SS
GDDULS 3175

TP-4201
SEPARATOR
1ST EFFECT
SIZE: 10'-6" Øx12'-0"
CAPACITY: 58,650 LB/HR
MATERIAL: 304L SS
25°FV @ 200°F

ET-4201
EVAPORATOR 1
1ST EFFECT
SIZE: 14,137 FT ² 66'-480
CAPACITY: 37,396 BTU/HR
MATERIAL: 304L SS
SS 23°FV @ 200°F


PC-4201
EVAP. RECIRC. PUMP
1ST STAGE
SIZE: 10x12-18-4V
CAPACITY: 2600 GPM @ 60'
MATERIAL: 316 SS
GDDULS 3175

PC-4205
1ST EFFECT CONDENSATE
PUMP
SIZE: 2x3-13
CAPACITY: 150 GPM @ 150'
MATERIAL: 316 SS
GDDULS 3196 MIX

 
TP-4205
1ST EFFECT CONDENSATE
COLLECTION TANK
SIZE: 3'-6" Ø x 6'-0"
CAPACITY: 420 L SS
MATERIAL: 304 L SS
25PSIG/ FV @ 200°F

ET-4205
CONDENSER
SIZE: 63.50 FT, 1'-0" Øx4'-0"
CAPACITY: 0.10 MBTU/HR
SS 100 PSIG @ 230°F -CS
SS 23 PSIG/FV @ 230°F
-304LSS

PV-4205
VACUUM PUMP
CAPACITY: 77 ACM @
10.2 PSIA, 100°F
MATERIAL: 316 SS

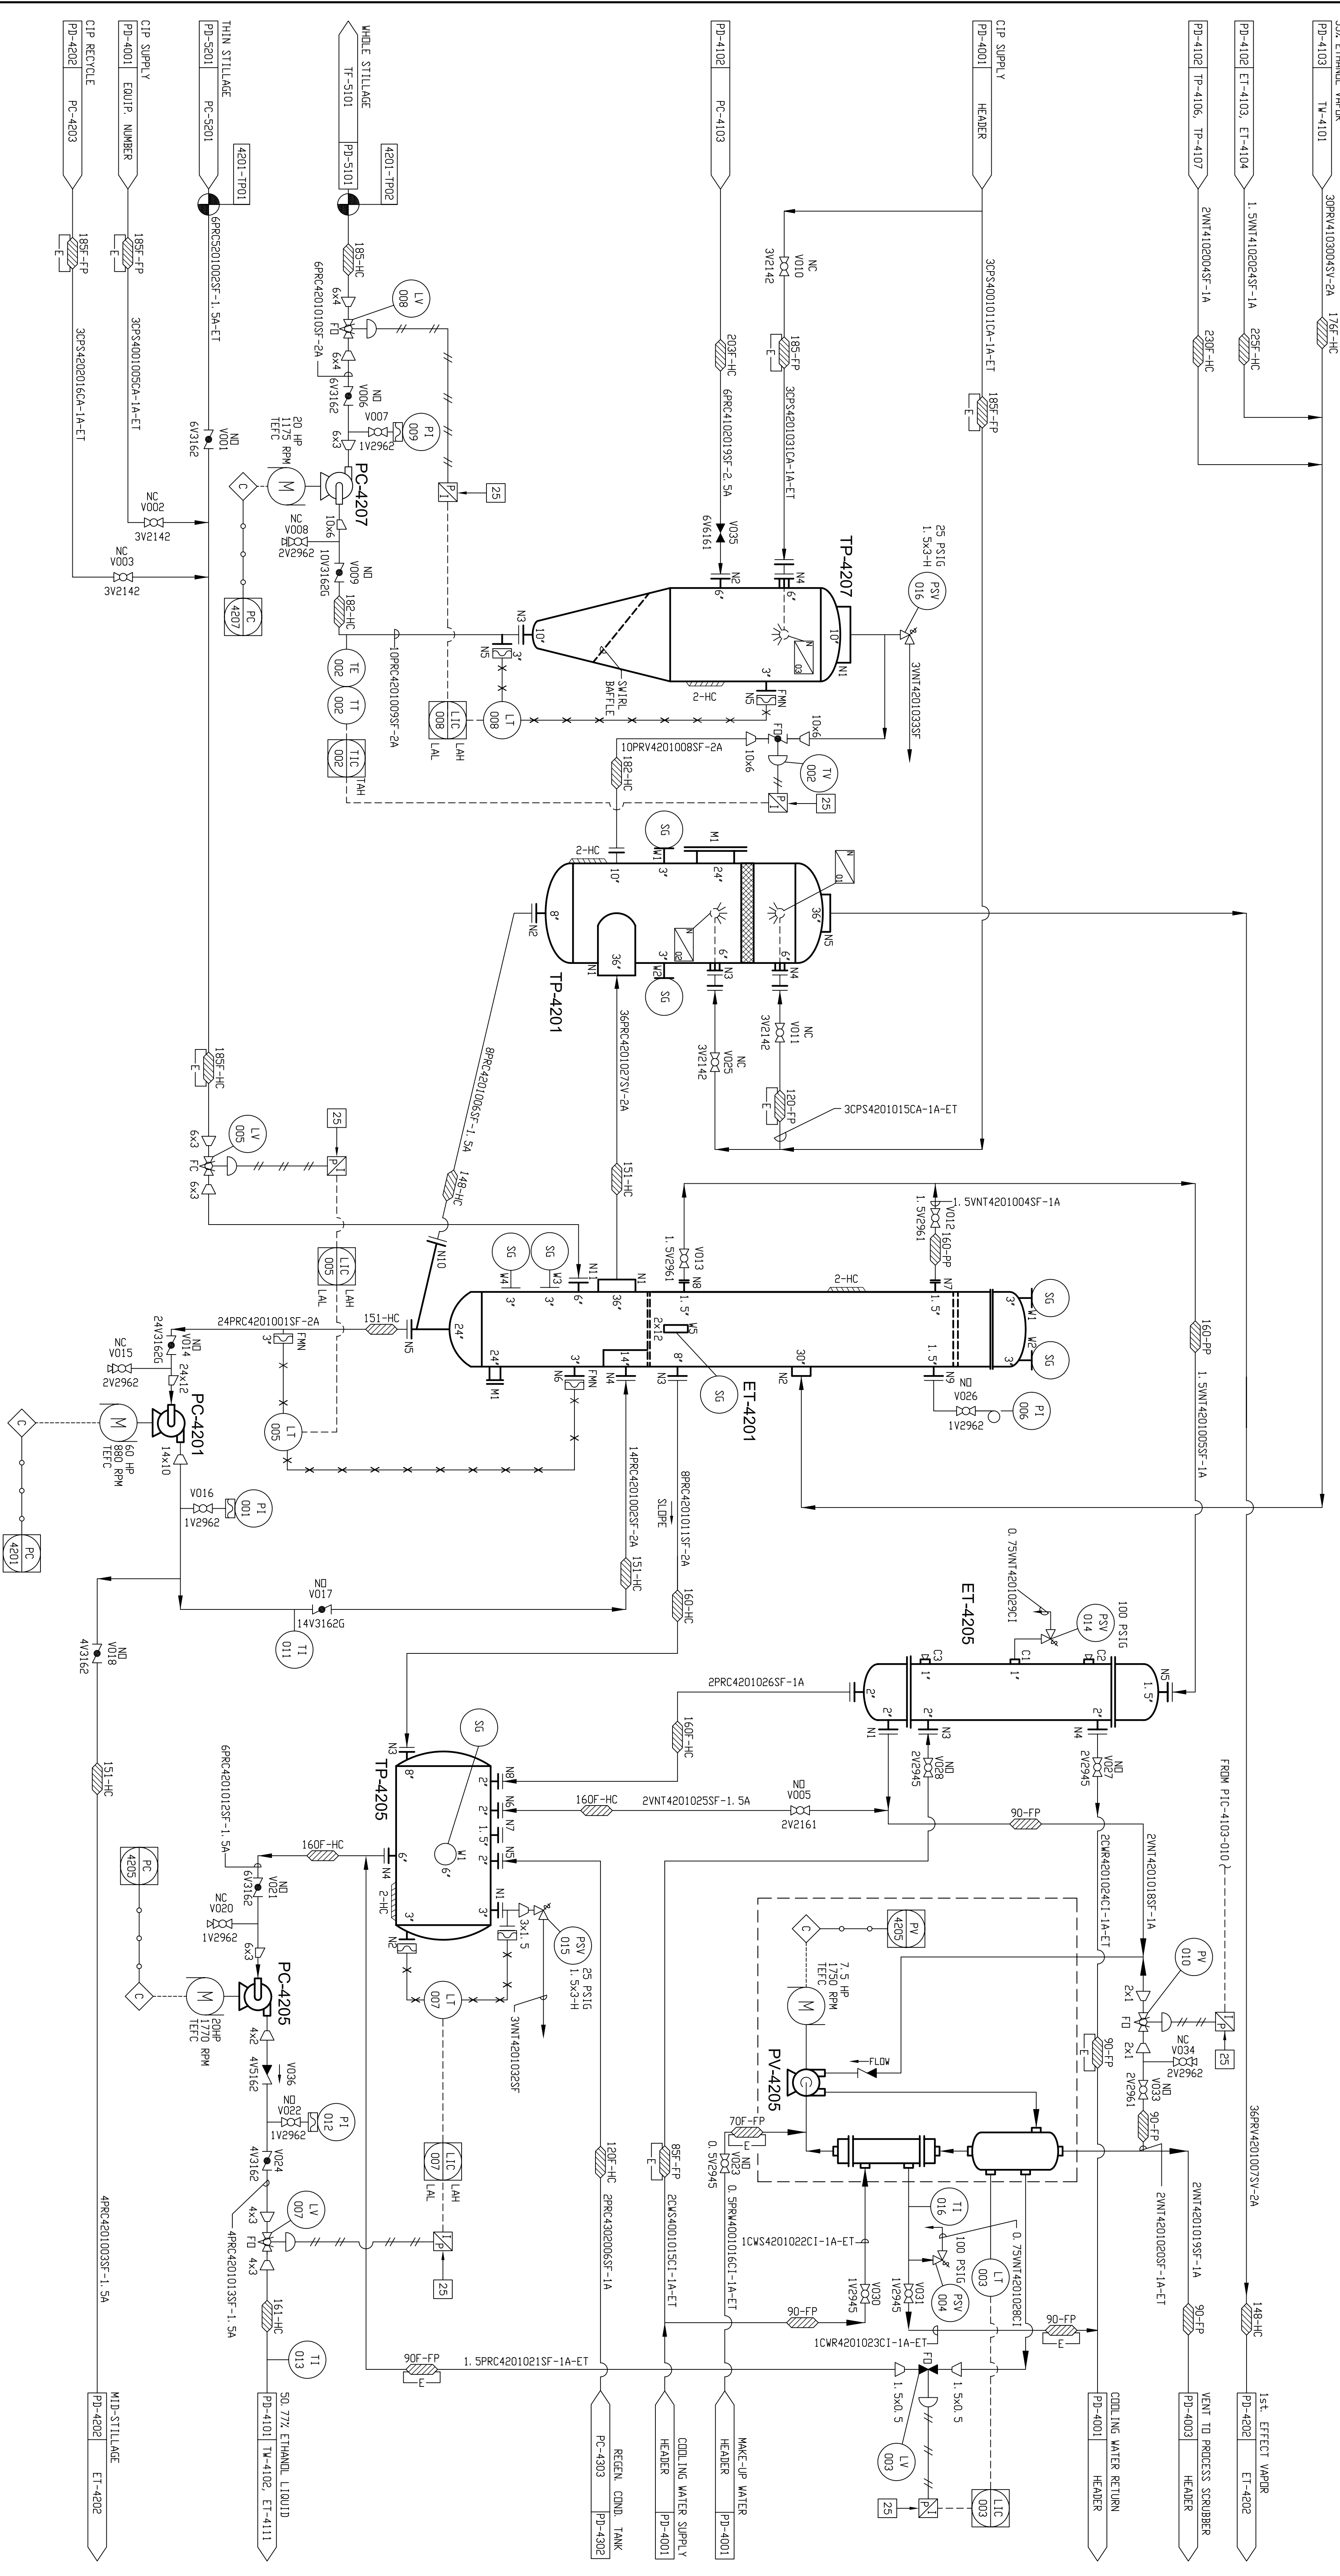

CONFIDENTIAL

 THERMAL KINETICS Engineering, PLLC & Systems, LLC Evaporation/Distillation/Chemical Reaction Process Design & Energy Conservation 667 Tift Street Buffalo, NY 14220										Distillation, Dehydration, Evaporation Piping & Instrumentation Diagram Evaporator 1st Effect									
SHEET NO.		75356-PD-4201-01-0		DATE		11-1-06		PROJECT NO.		NONE									
SHEET NO.		1 of 1		DATE		6018-PD-4201		PROJECT NO.		0									

THIS DRAWING IN DESIGN AND DETAIL, IS THE PROPERTY OF THERMAL KINETICS, INC. IT IS NOT TO BE USED FOR ANY PURPOSE OTHER THAN THAT FOR WHICH IT WAS ORIGINALLY PREPARED. THE RIGHT OF DESIGN AND INVENTION ARE RESERVED. COPYRIGHT 2006		SIZE	D
REV.	RELEASED FOR DETAIL DESIGN	DATE	11-15-06
0		BY	JL
1		CHKD	
2		APPD	
3			
4			
5			
200			